




- THIS DRAWING IS TO BE READ IN CONJUNCTION WITH ALL ENGINEERS & ARCHITECTS DRAWINGS FIGURED DIMENSIONS ONLY (NOT SCALING) TO BE USED, WHERE A CONFLICT OF INFORMATION EXISTS OR IF IN ANY DOUBT - ASK.
- CONSULTANTS TO BE INFORMED IMMEDIATELY OF ANY DISCREPANCIES BEFORE WORK PROCEEDS.

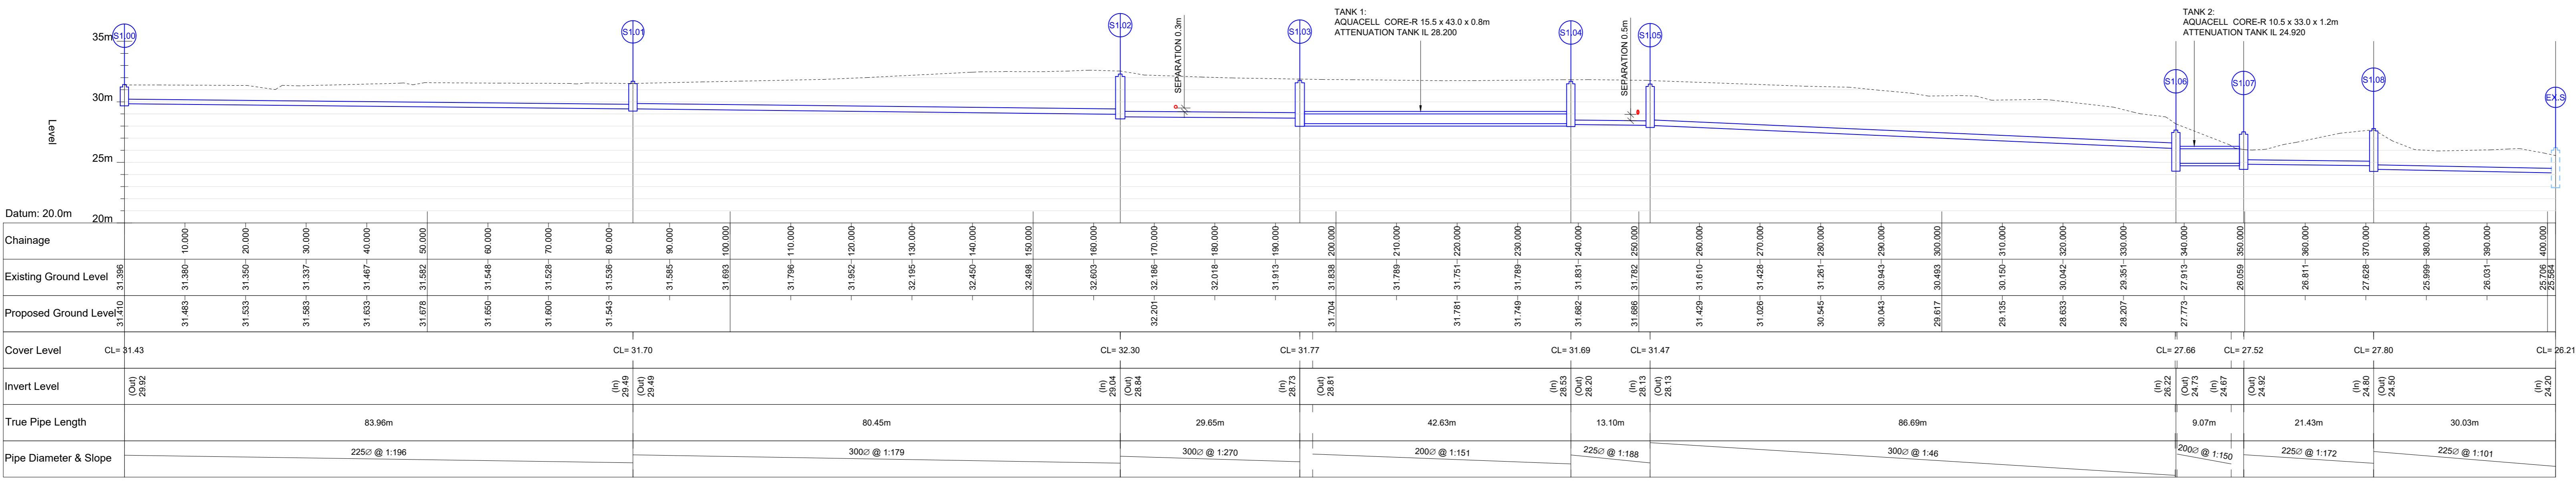


S1 SECTION
SCALE @ A0: H=1:500, V=1:250
SCALE @ A2: H=1:1000, V=1:500

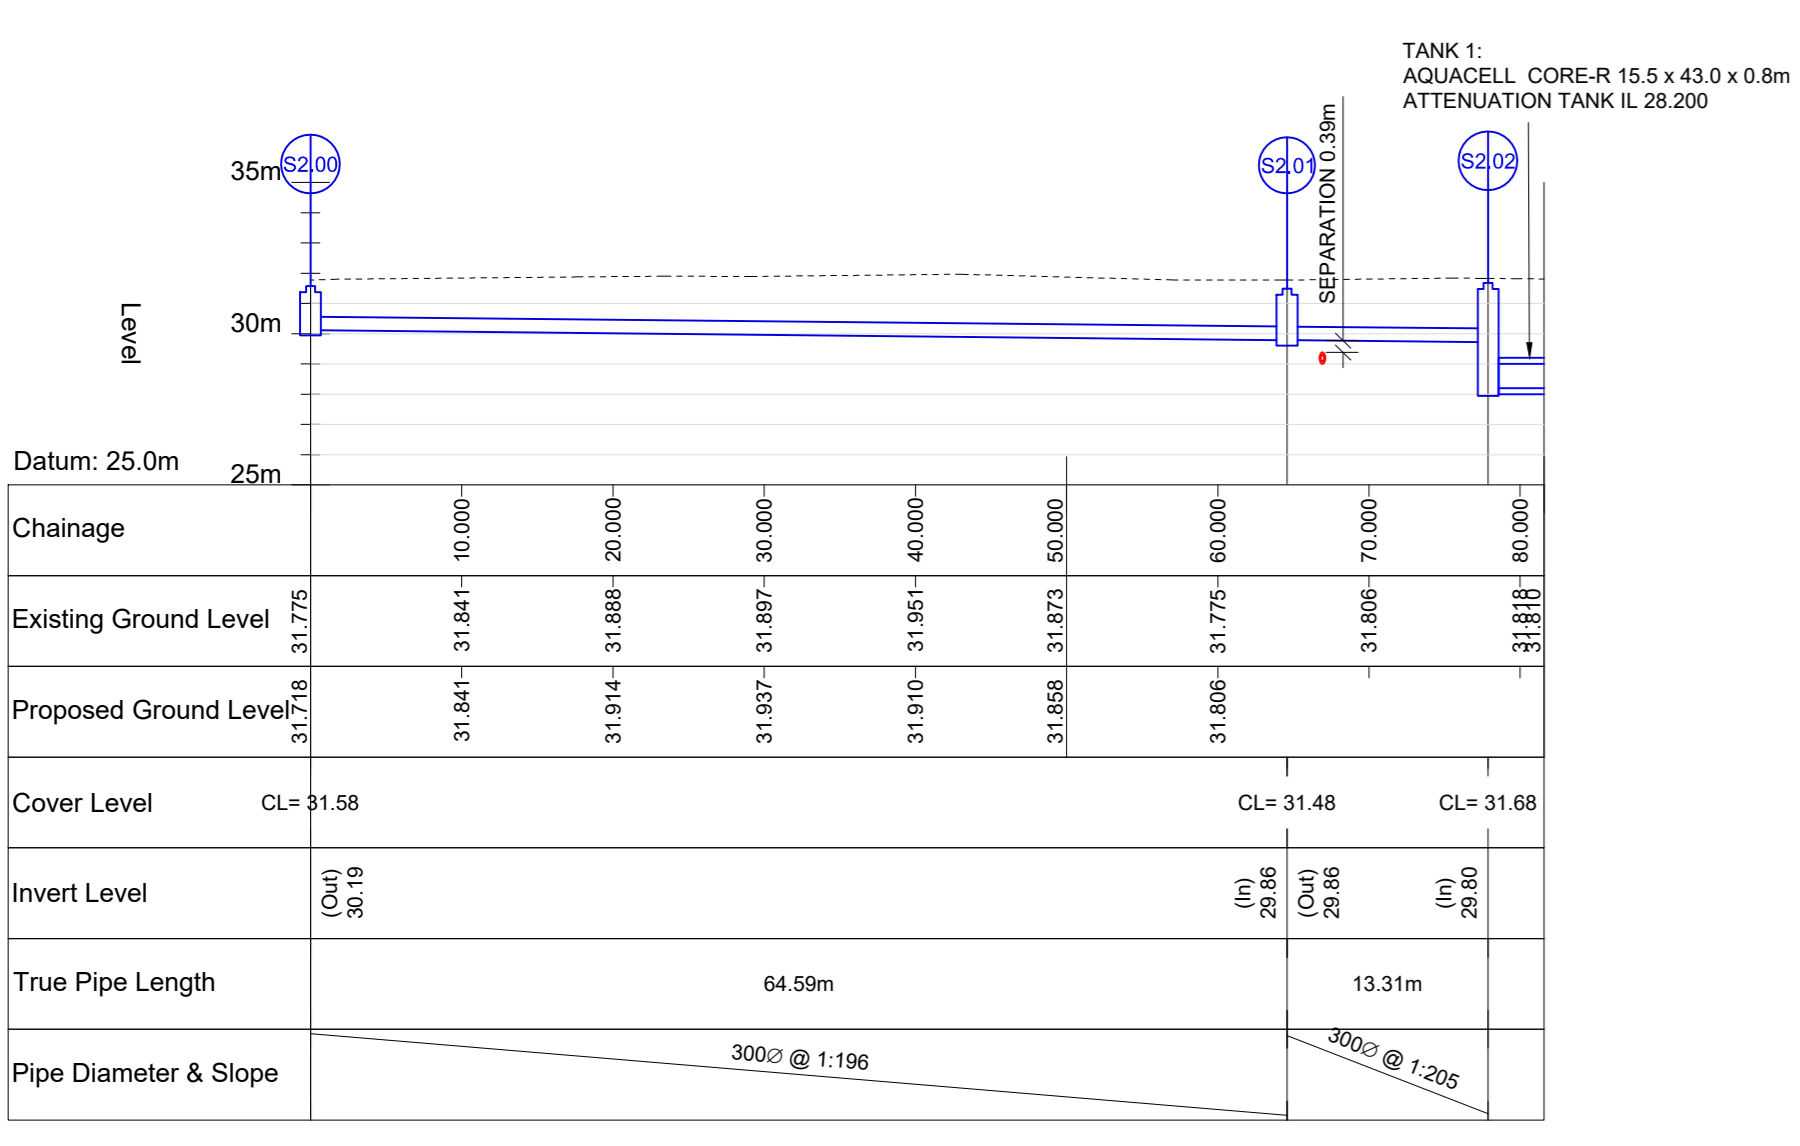


S2 SECTION
SCALE @ A0: H=1:500, V=1:250
SCALE @ A2: H=1:1000, V=1:500

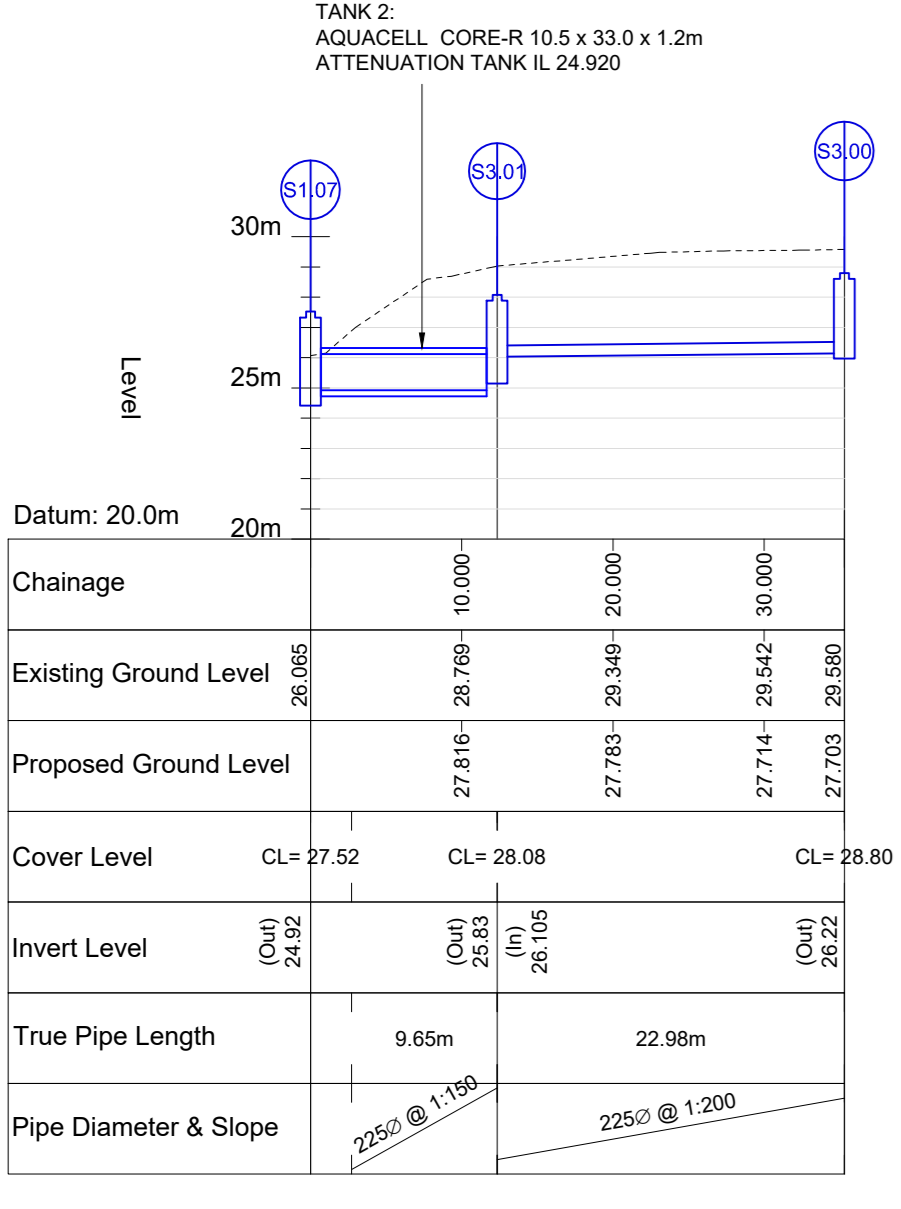


S3 SECTION
SCALE @ A0: H=1:500, V=1:250
SCALE @ A2: H=1:1000, V=1:500

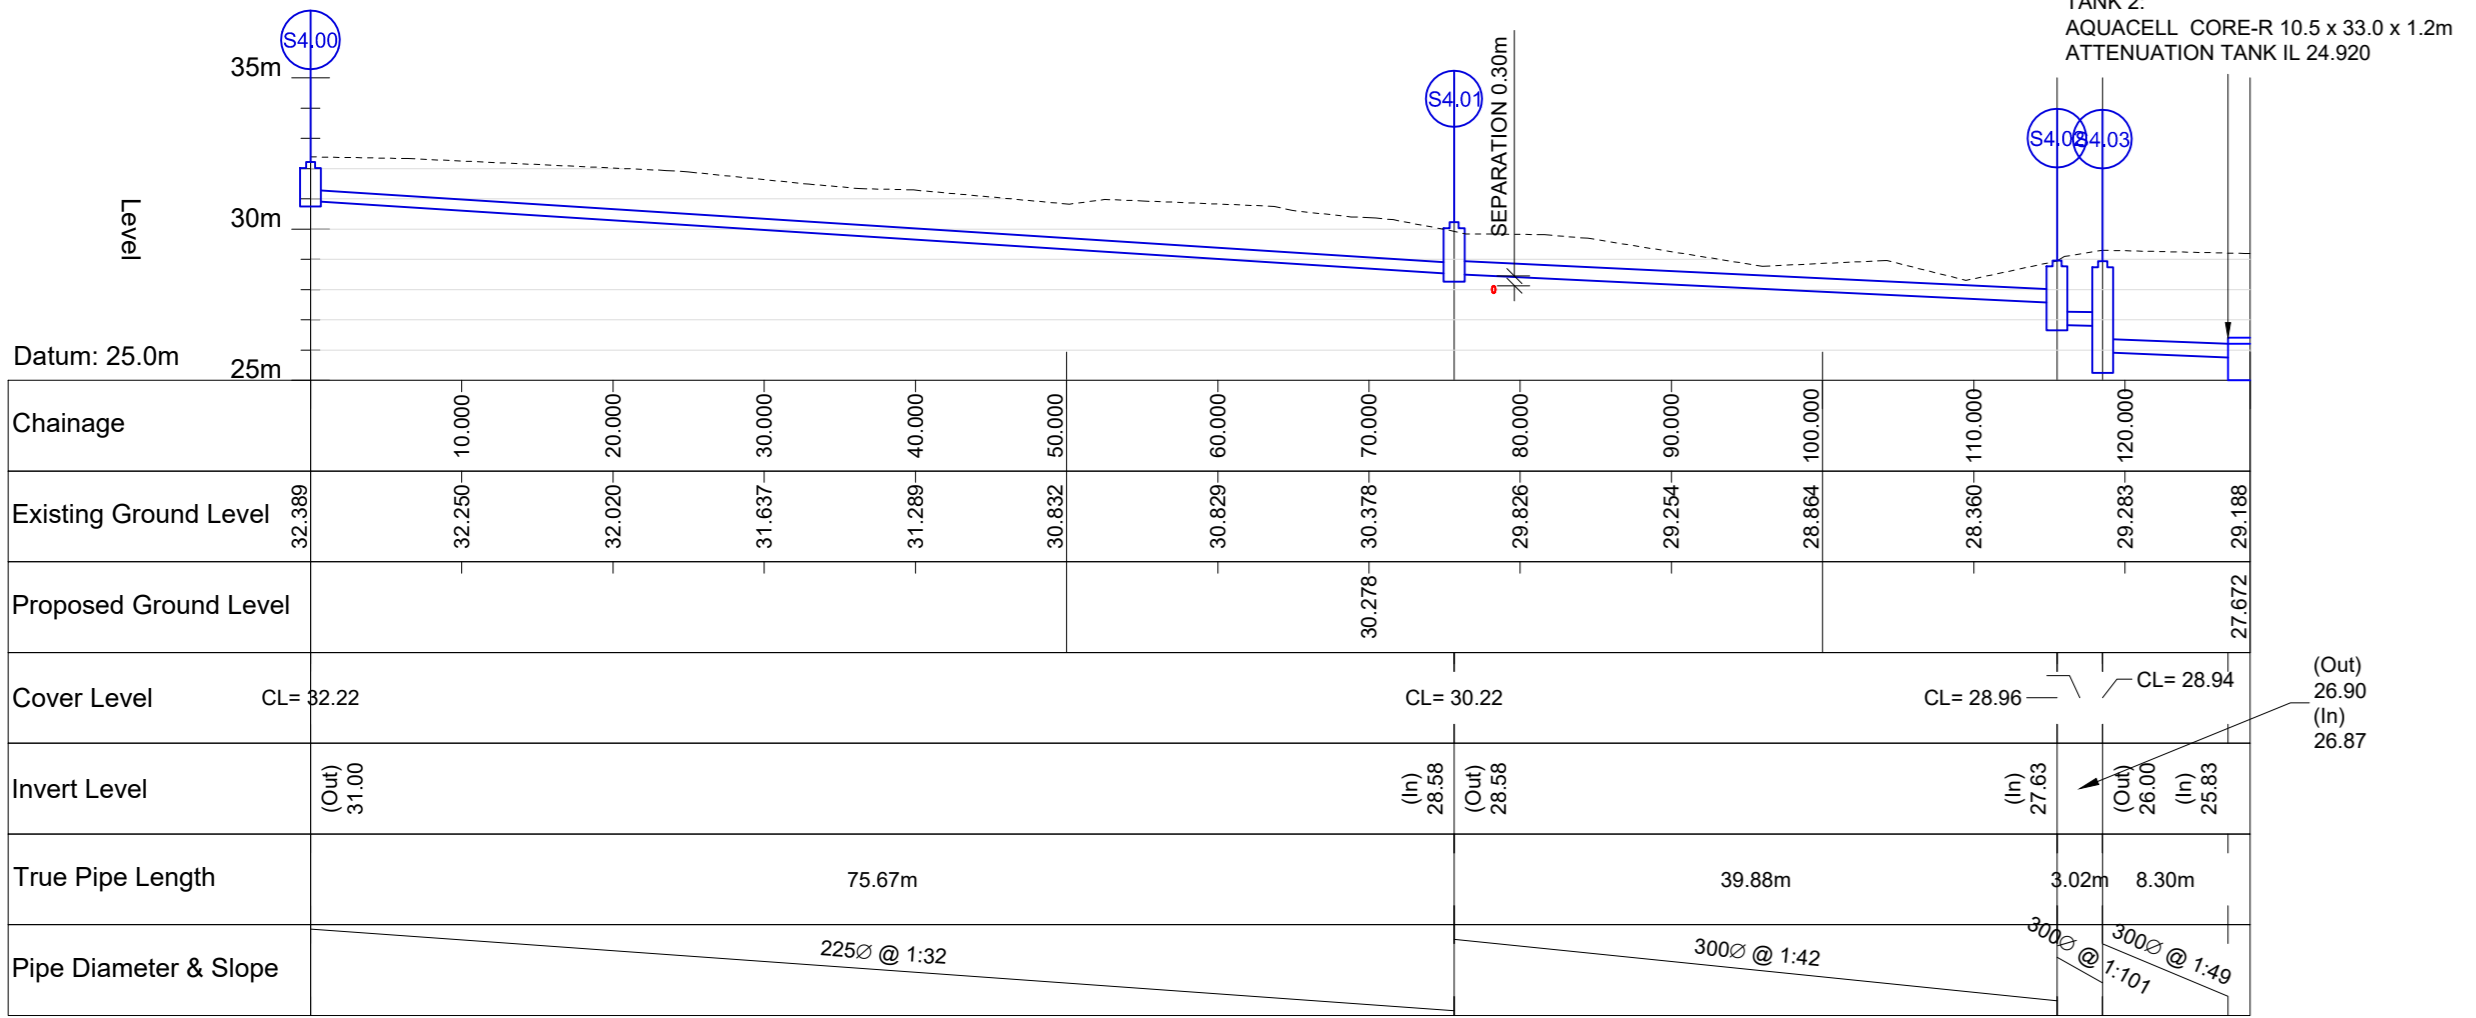

S4 SECTION
SCALE @ A0: H=1:500, V=1:250
SCALE @ A2: H=1:1000, V=1:500

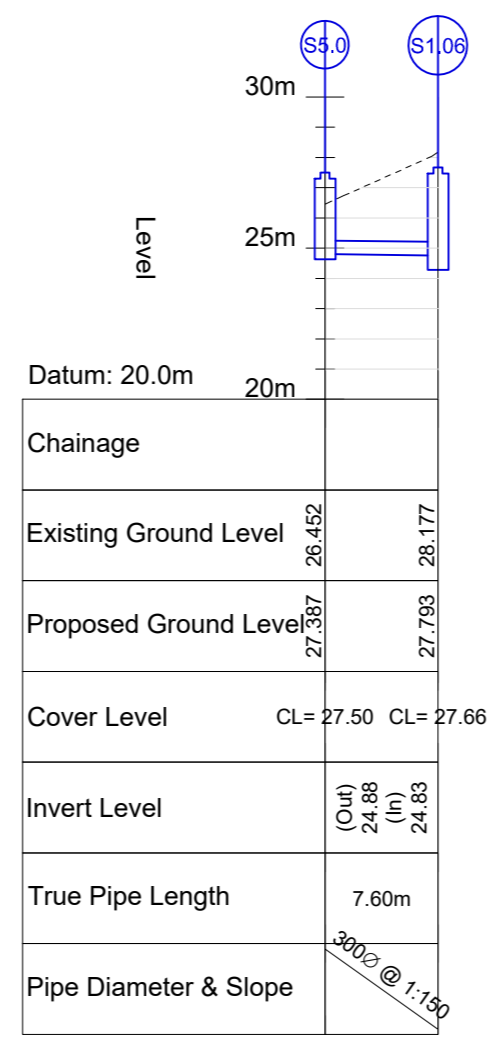

S5 SECTION
SCALE @ A0: H=1:500, V=1:250
SCALE @ A2: H=1:1000, V=1:500

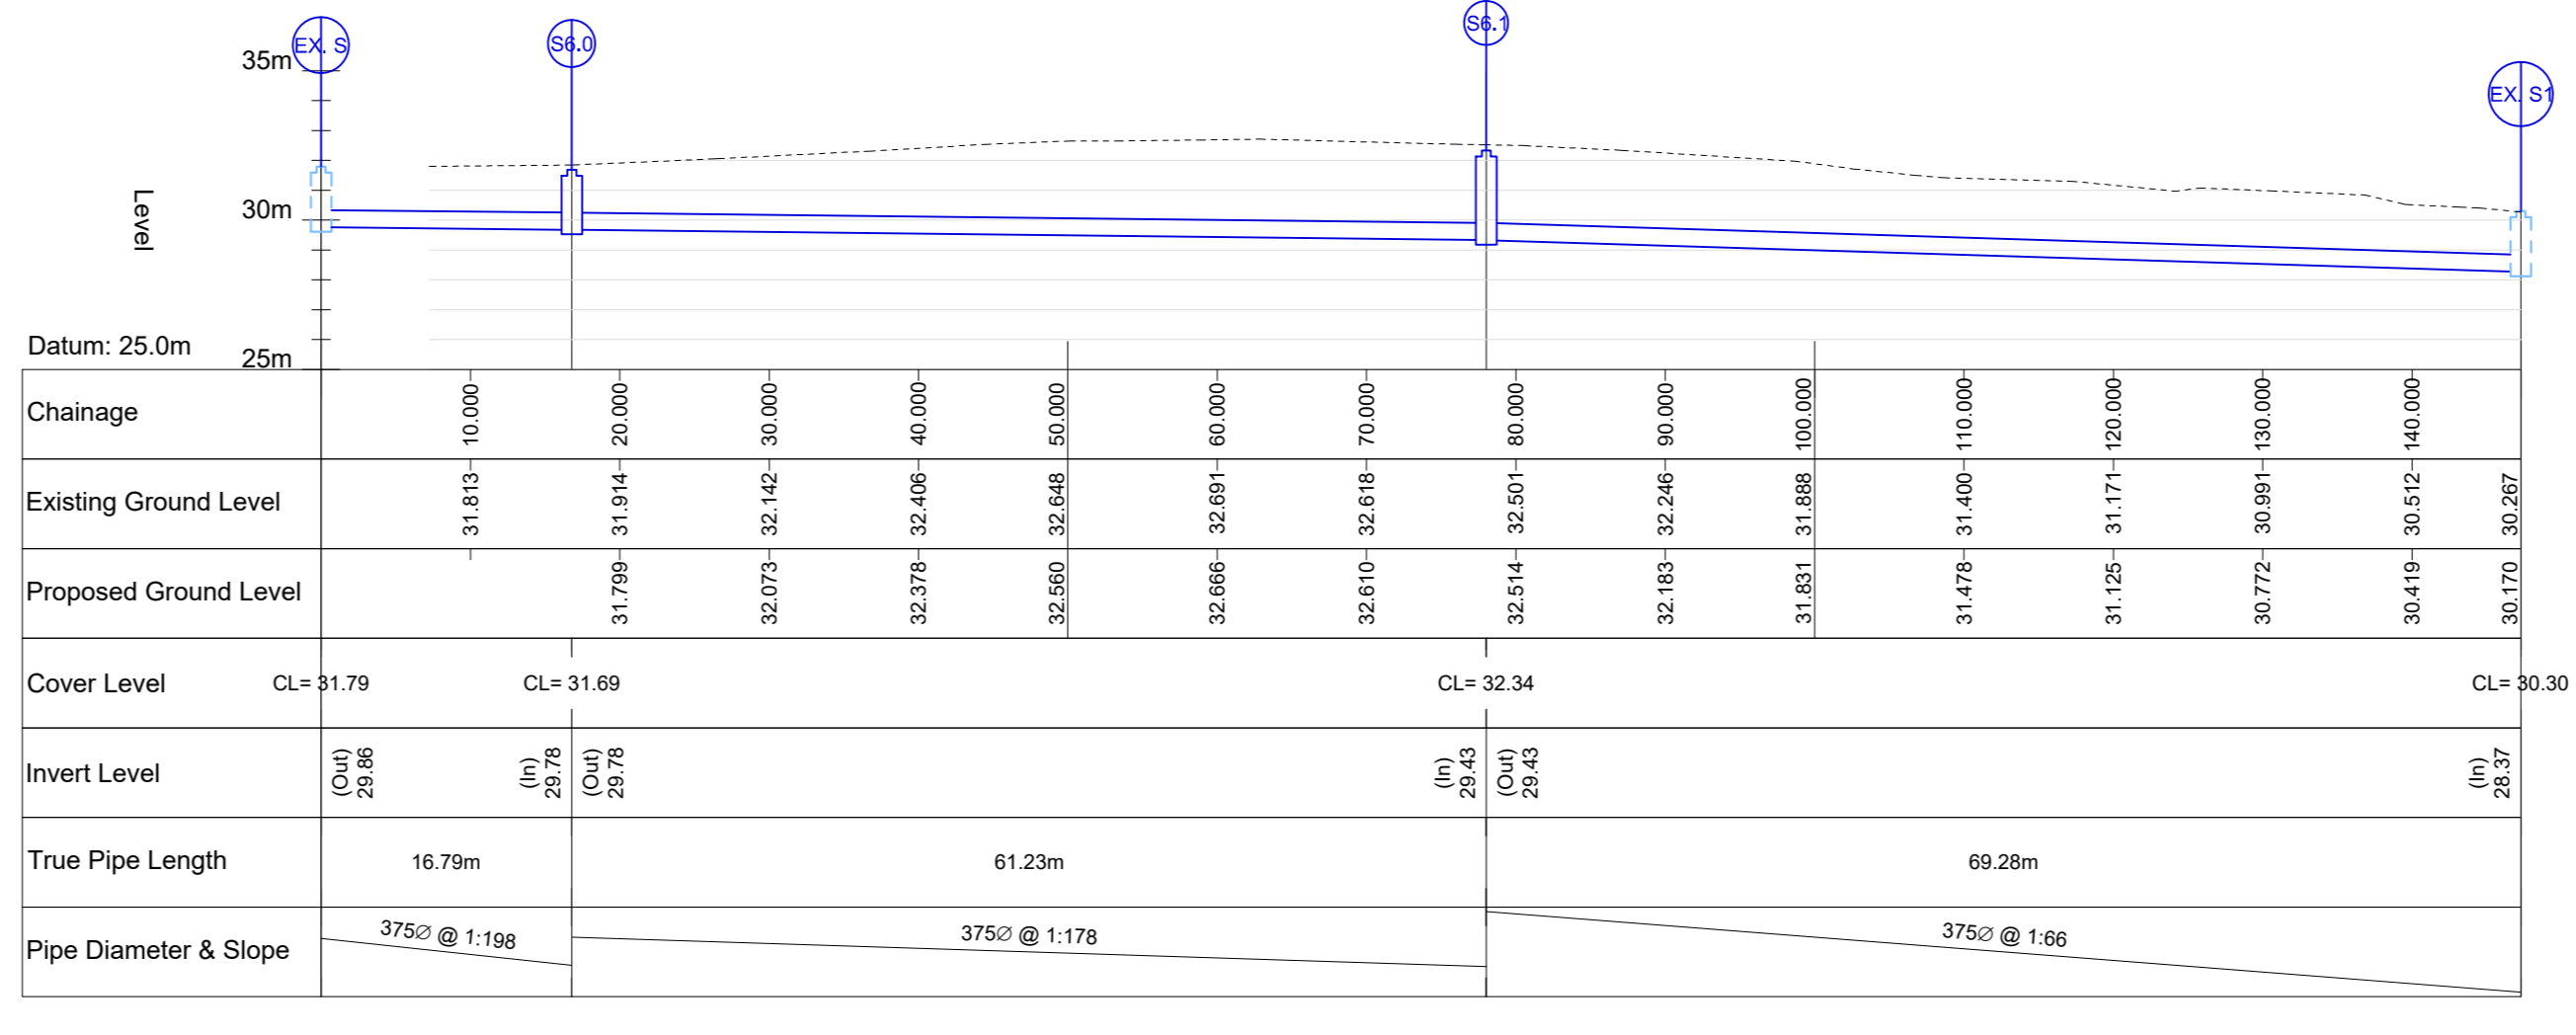

S6 SECTION
SCALE @ A0: H=1:500, V=1:250
SCALE @ A2: H=1:1000, V=1:500

ISSUE	DATE	DESCRIPTION	DRG	P	C
PL6	22.06.21	ISSUED FOR PLANNING	SM	SM	SM
PL5	28.05.21	ISSUED FOR PLANNING	SM	SM	SM
PL4	18.03.21	ISSUED FOR PLANNING	SM	SM	SM
PL3	05.02.21	ISSUED FOR PLANNING	SM	SM	SM
PL2	26.10.20	RE-ISSUED FOR I.W. APPROVAL	SM	SM	SM
PL1	24.04.20	ISSUED FOR I.W. APPROVAL	SM	SM	SM

DRAWING STAGE: **PLANNING**

BM Dublin Office
Sawthill House, 53-54 Lower Sawthill Street, Dublin 2, Ireland
Tel: 011 677 2300 Fax: 011 677 2164

BAFFRETT MANDRY London Office
12 Mill Street, London SE1 3AY, United Kingdom
Tel: (0)44 (0)4 5413 2722

Consulting Engineers, Civil, Structural, Project Management & Health & Safety
www.bm.co.uk

The Institution of Structural Engineers **ACEI**

CLIENT: **GREEN URBAN LIVING N11 LTD.**

PROJECT TITLE: WYATTVILLE PARK BTR, LOUGHLINSTOWN, CO. DUBLIN	BM PROJECT No: 19.207
MODEL REFERENCE: 19207-BM-C3D-M-DRAINAGE	MODEL REV: SCALE AS SHOWN

DRAWING TITLE: **PROPOSED DRAINAGE LAYOUT - SW SECTIONS**

DRAWING No: LOU-BMD-00-ZZ-DR-C-1100	DATE: PL6
--	------------------